


MASTER BATHROOM - INTERIOR CAD PACKAGE

SHEET 01 GENERAL ARRANGEMENT PLAN

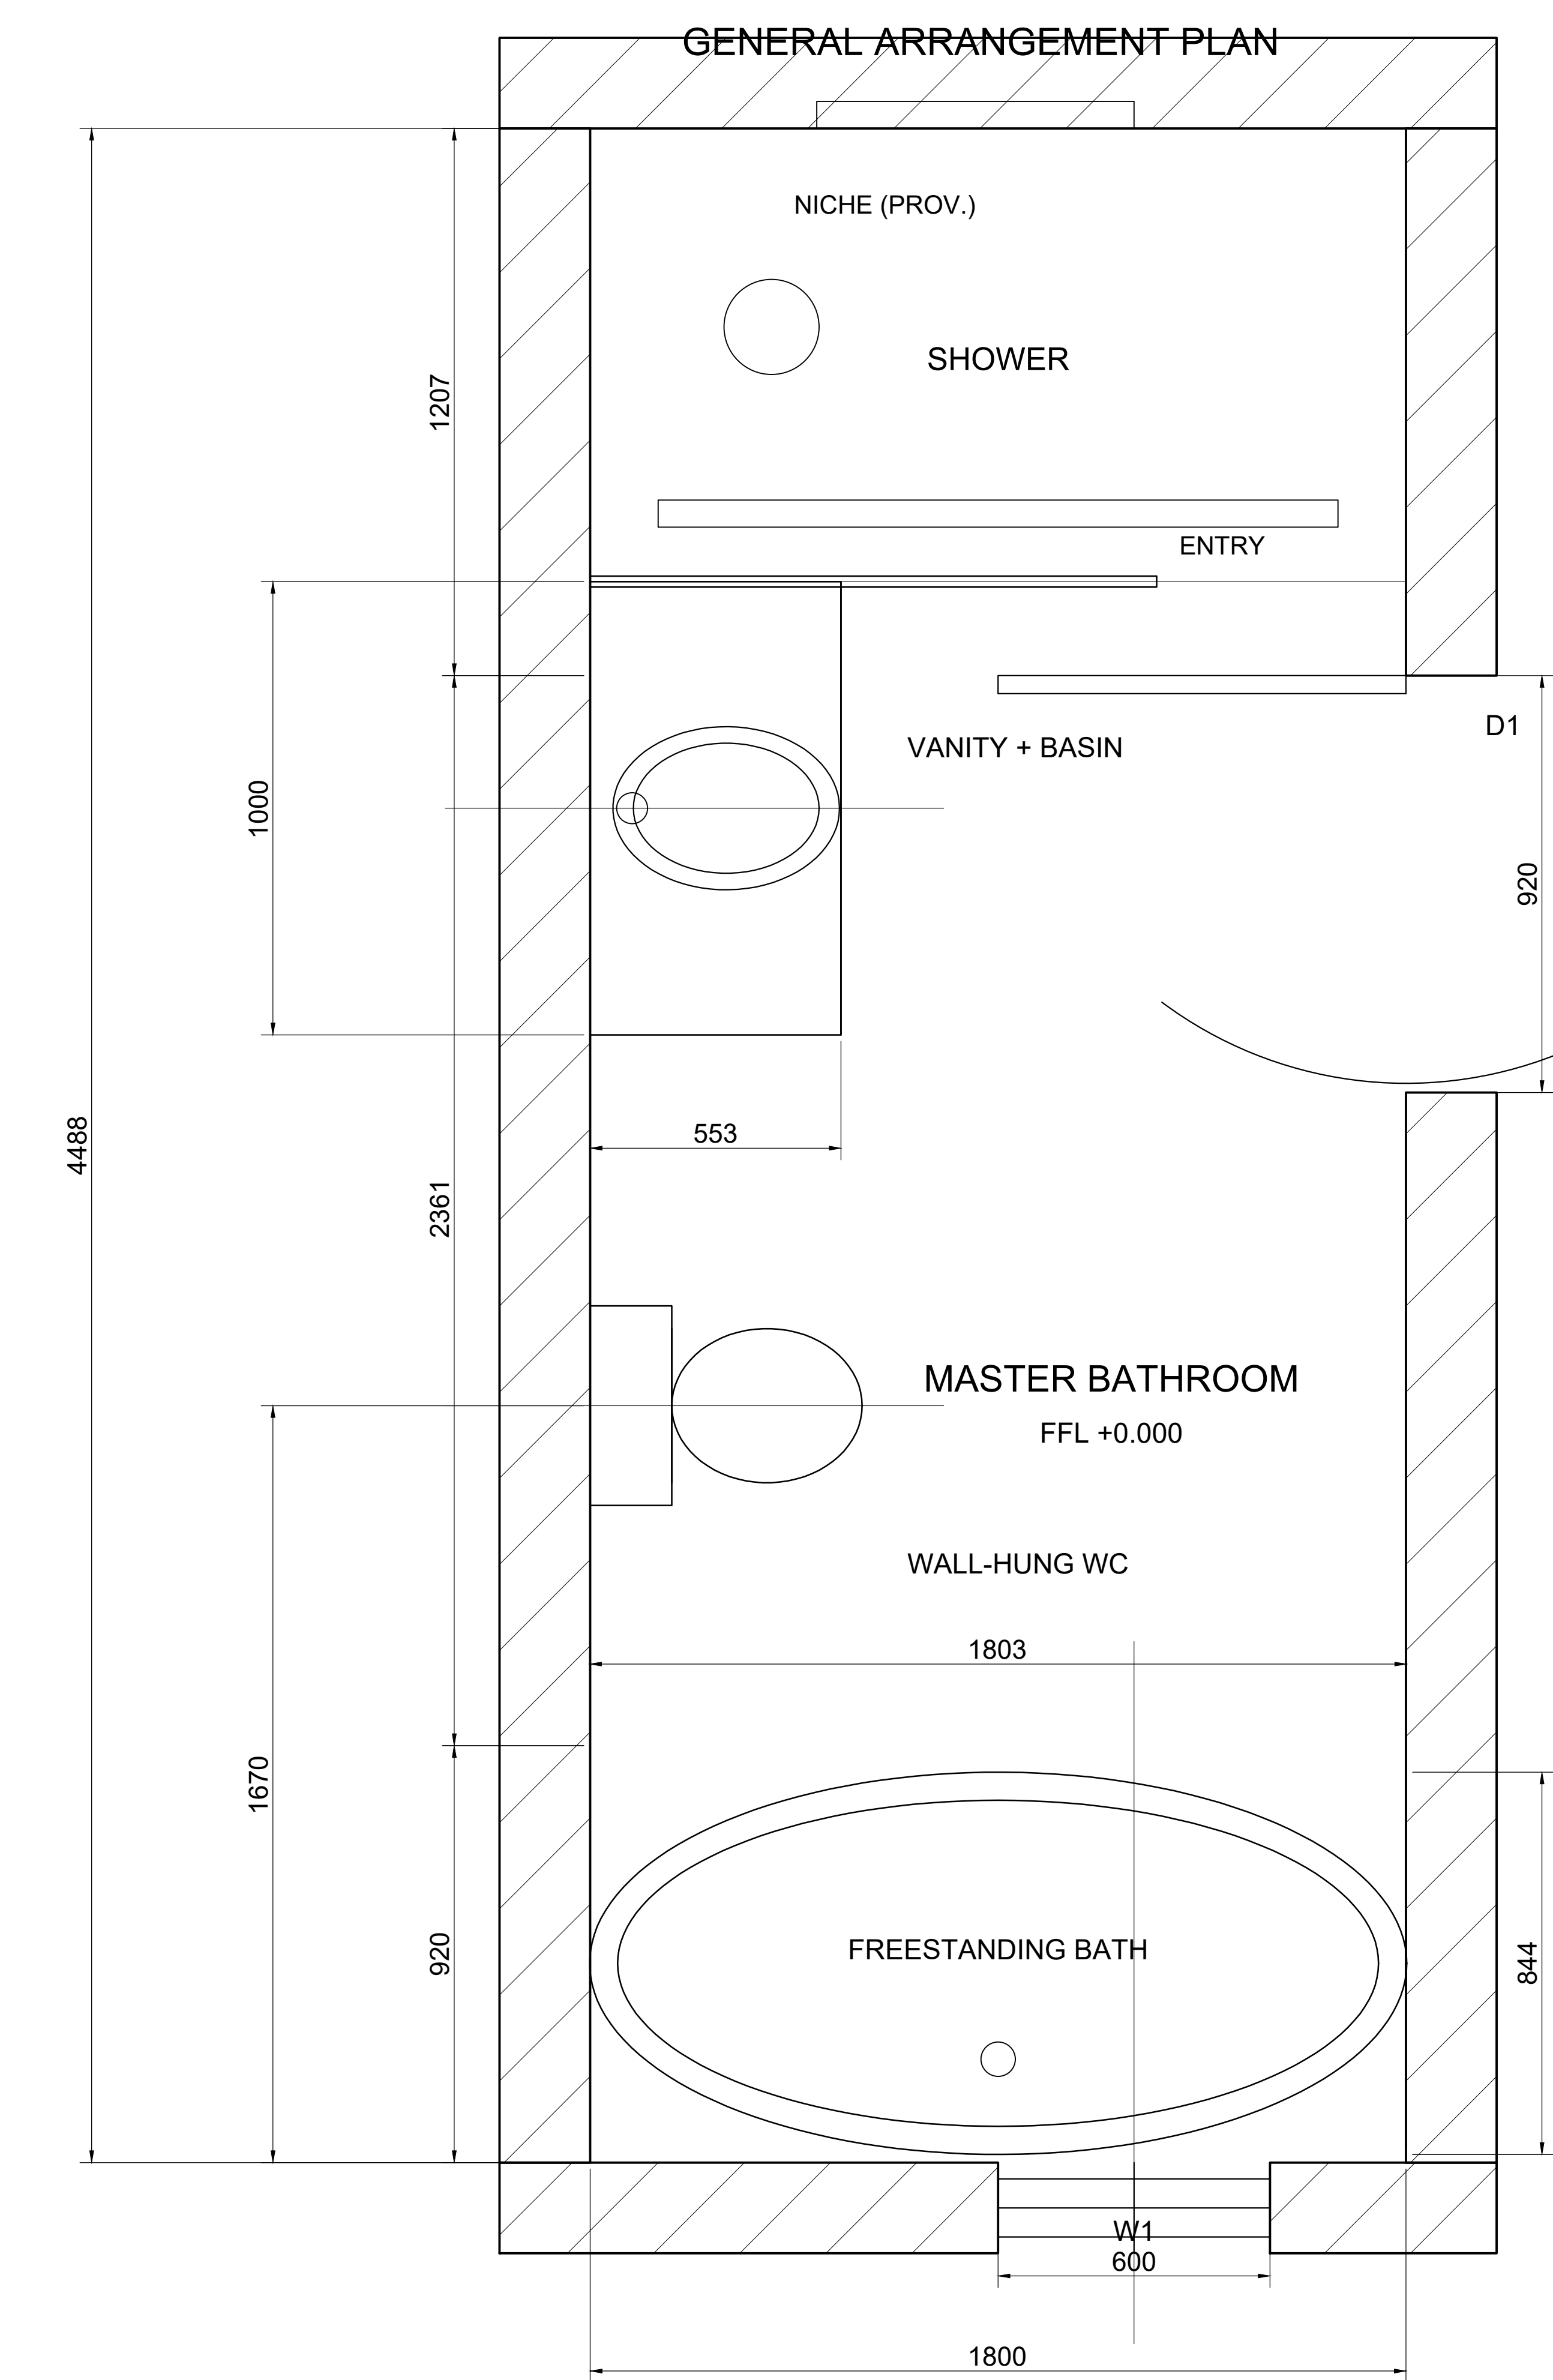

FIXTURE SCHEDULE

TUB	FREESTANDING BATH 1803 x 844, WALL TO WALL
WC	WALL-HUNG PAN, CONCEALED CISTERN (PROV.)
VAN	VANITY 1000 x 553, TOP AT 900 AFF
BAS	UNDERMOUNT BASIN, WALL-MOUNTED TAP
SHR	SHOWER 1800 x 1000, FLOOR WASTE
D1	900 LEAF / 920 OPENING, HINGE NORTH
W1	WINDOW 600 x 1800, SILL 800 AFF

CONFIRMED DIMENSIONS

CEILING HEIGHT	3200
WINDOW WIDTH	600
WINDOW HEIGHT	1800
WINDOW SILL AFF	800
WINDOW HEAD AFF	2600
ROOM INTERNAL WIDTH	1800
ROOM INTERNAL LENGTH	4488

GENERAL NOTES

- ALL DIMENSIONS IN MILLIMETRES.
- MODEL GEOMETRY IS 1:1. DO NOT SCALE.
- CONTRACTOR TO VERIFY ALL SITE DIMENSIONS BEFORE FABRICATION.
- DIMENSIONS SUFFIXED PROV. ARE PROPORTIONED FROM THE SUPPLIED REFERENCES AND REQUIRE CONFIRMATION.
- ITEMS ON LAYER 20-PROVISIONAL ARE INDICATIVE.
- WINDOW SILL REVISED FROM 600 TO 800 AFF PER LATEST CLIENT INSTRUCTION.

MATERIAL LEGEND

M1	MOSAIC FLOOR TILE, LIGHT BEIGE
M2	VERTICAL WALL TILE / CLADDING
M3	PAINTED PANELLED JOINERY
M4	STONE VANITY TOP
M5	BRUSHED BRASS SANITARYWARE
M6	CLEAR TOUGHENED SHOWER GLASS

PLAN KEY

WALL 1	SOUTH - BATHTUB + WINDOW	(SHEET 02)
WALL 2	WEST - VANITY + WC	(SHEET 03)
WALL 3	NORTH - SHOWER	(SHEET 04)
WALL 4	EAST - ENTRANCE / DOOR	(SHEET 05)

PLAN ORIENTATION TAKEN FROM THE SUPPLIED
DIMENSIONED CAD PLAN REFERENCE.

DIMENSION CHAIN CHECK

SOUTH TUB ZONE	920
MIDDLE WC + VANITY ZONE	2361
NORTH SHOWER ZONE	1207
OVERALL INTERNAL LENGTH	4488

CHAIN AGREES WITH THE PLAN REFERENCE.

RED CHANDELIER STUDIO

SHEET 01


GENERAL ARRANGEMENT PLAN

SCALE 1:10 @ A1

UNITS mm REV V02
STATUS FOR CLIENT REVIEW

MASTER BATHROOM - INTERIOR CAD PACKAGE

SHEET 02 WALL 1 BATHTUB + WINDOW ELEVATION

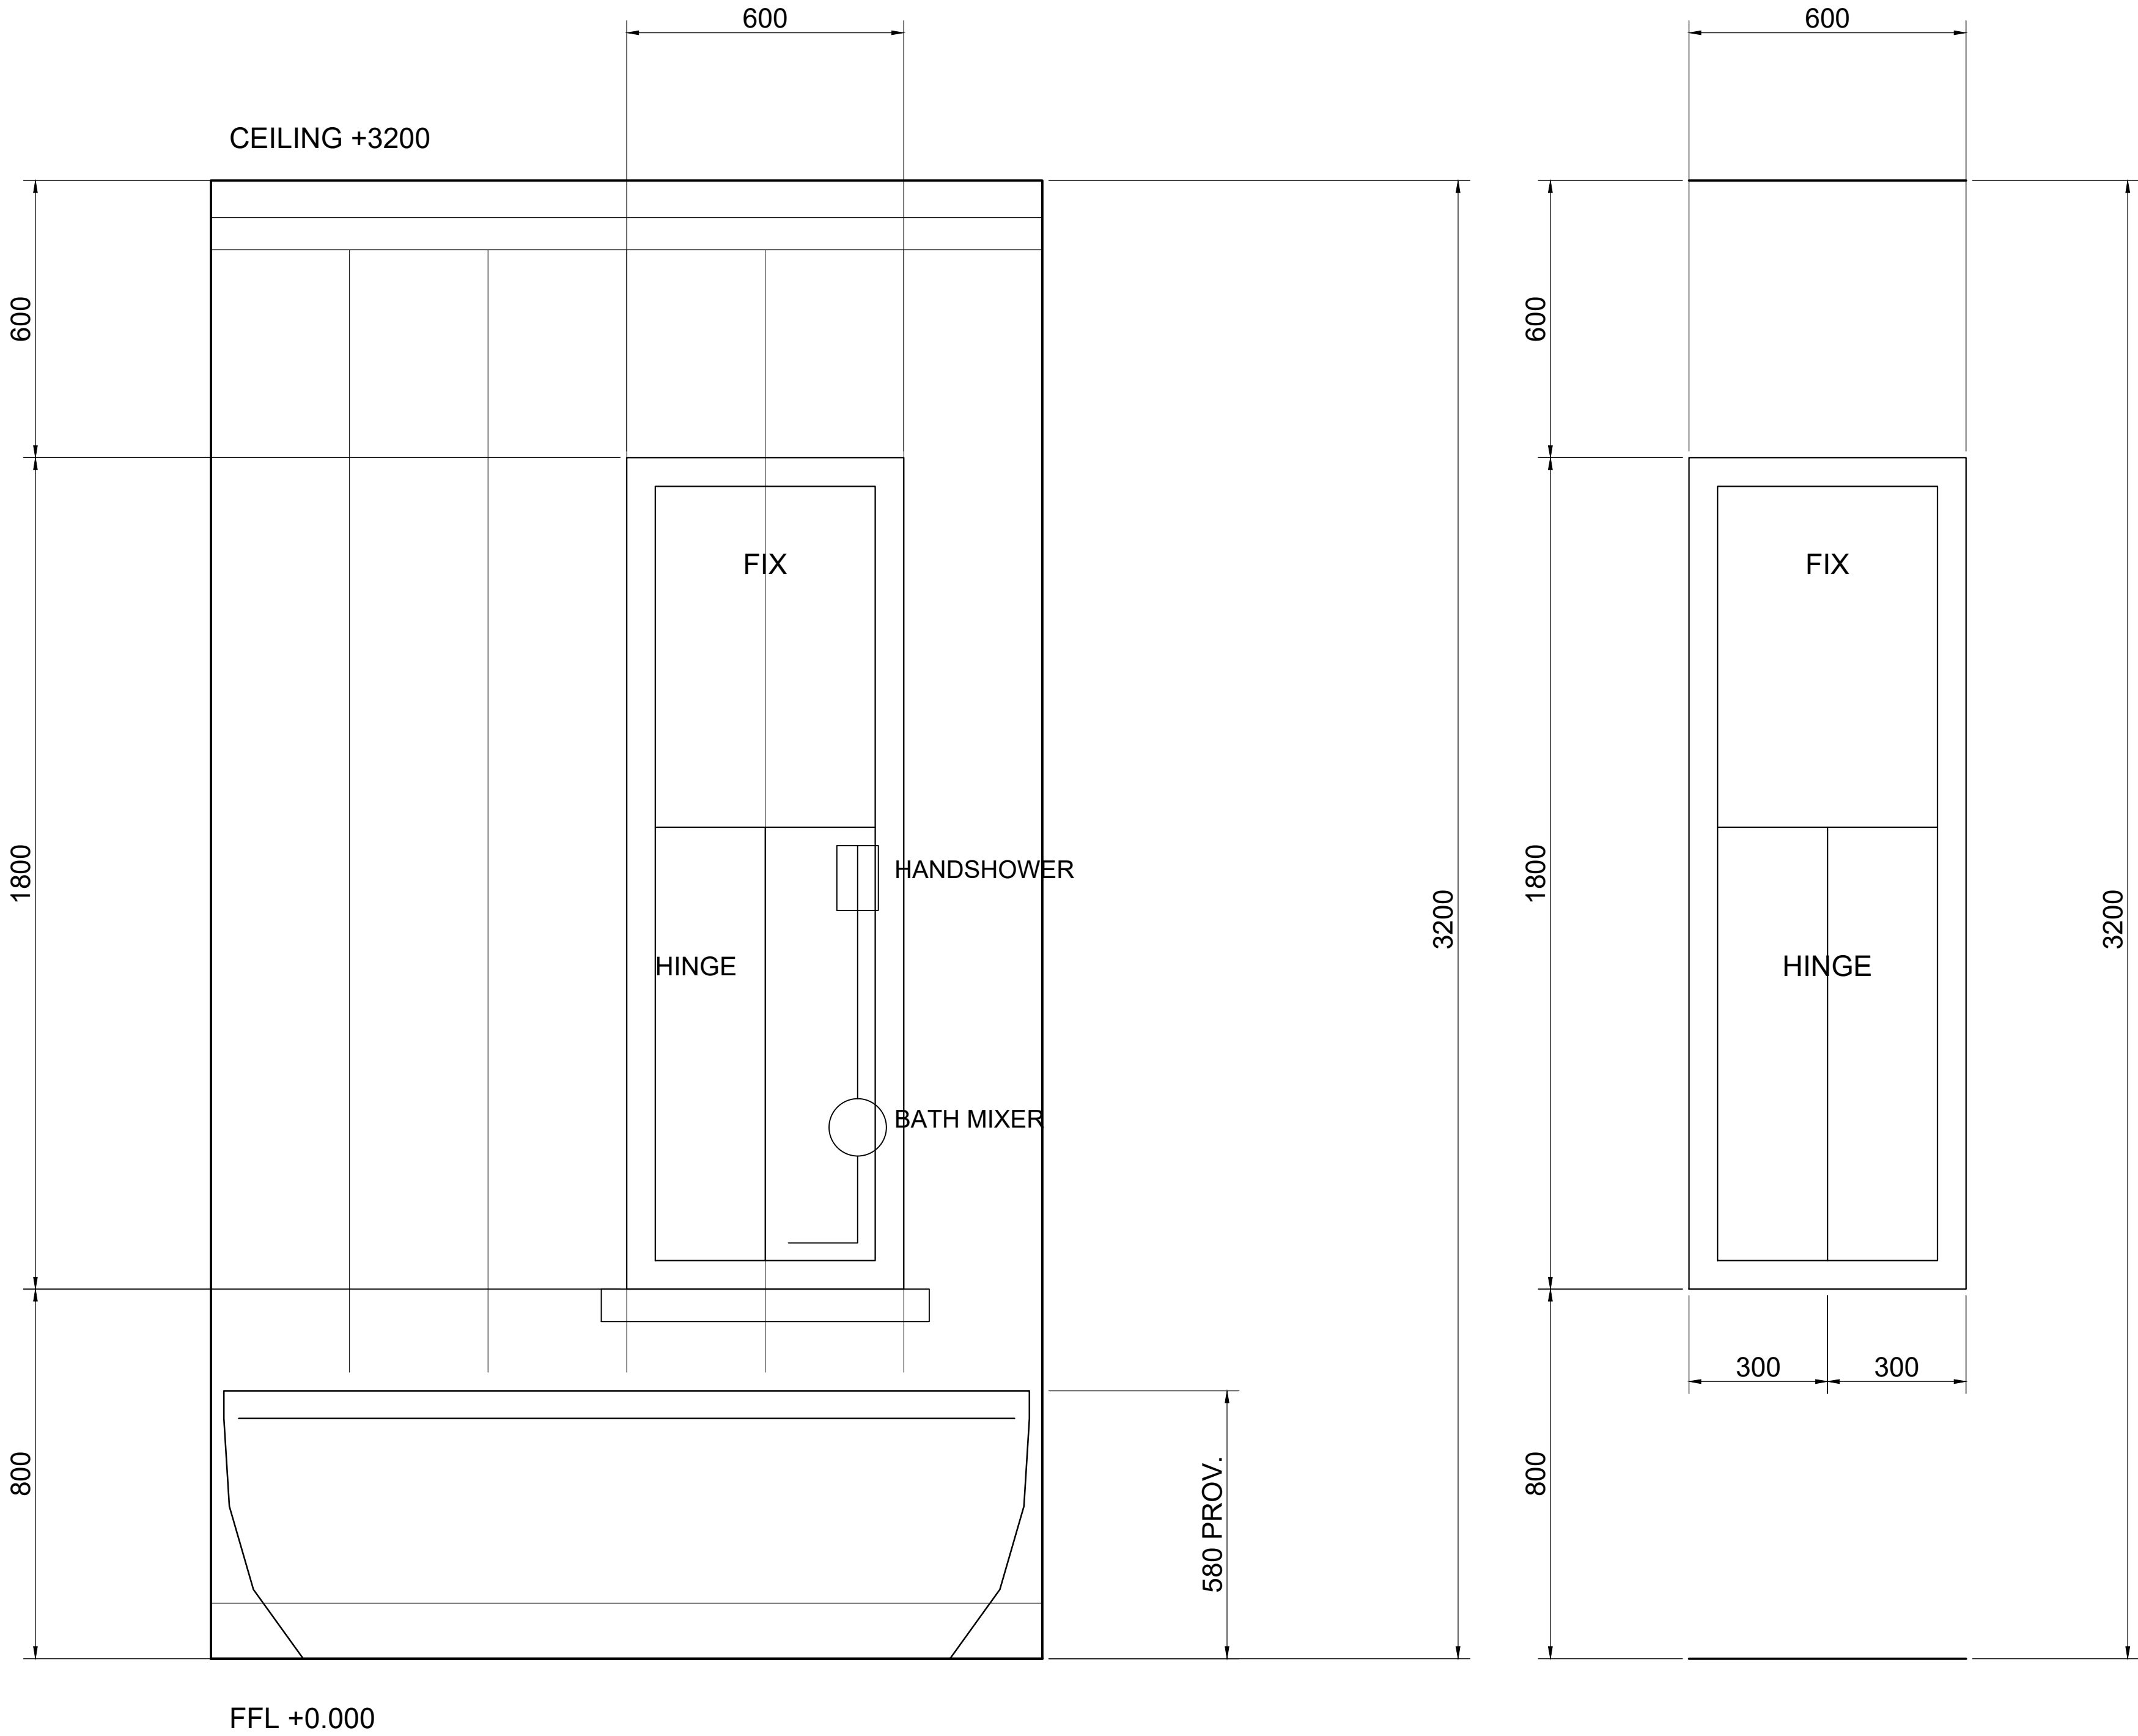

WALL 1 NOTES

- 1. FREESTANDING BATH CENTRED ON THE WINDOW.
- 2. WINDOW 600 x 1800, SILL 800 AFF, HEAD 2600 AFF.
- 3. FIXED UPPER PANEL 800 HIGH PER WINDOW DETAIL;
HINGED LOWER PANEL 300 + 300 LEAVES.
- 4. WALL-MOUNTED BATH MIXER AND HANDSHOWER TO
THE WEST OF THE WINDOW PER REFERENCE.
- 5. VERTICAL TILE CLADDING ABOVE DADO.
- 6. TUB SIZE AND RIM HEIGHT PROPORTIONED FROM
REFERENCE - CONFIRM IF REQUIRED.

WINDOW W1 DETAIL

600 WIDE x 1800 HIGH - SILL 800 AFF


WALL 1 - BATHTUB + WINDOW

VIEW LOOKING SOUTH (left = EAST, right = WEST)

RED CHANDELIER STUDIO		SHEET 02	
WALL 1 BATHTUB + WINDOW ELEVATION			
SCALE 1:10 @ A1		UNITS mm	REV V02
		STATUS FOR CLIENT REVIEW	

MASTER BATHROOM - INTERIOR CAD PACKAGE

SHEET 03 WALL 2 VANITY + WC ELEVATION

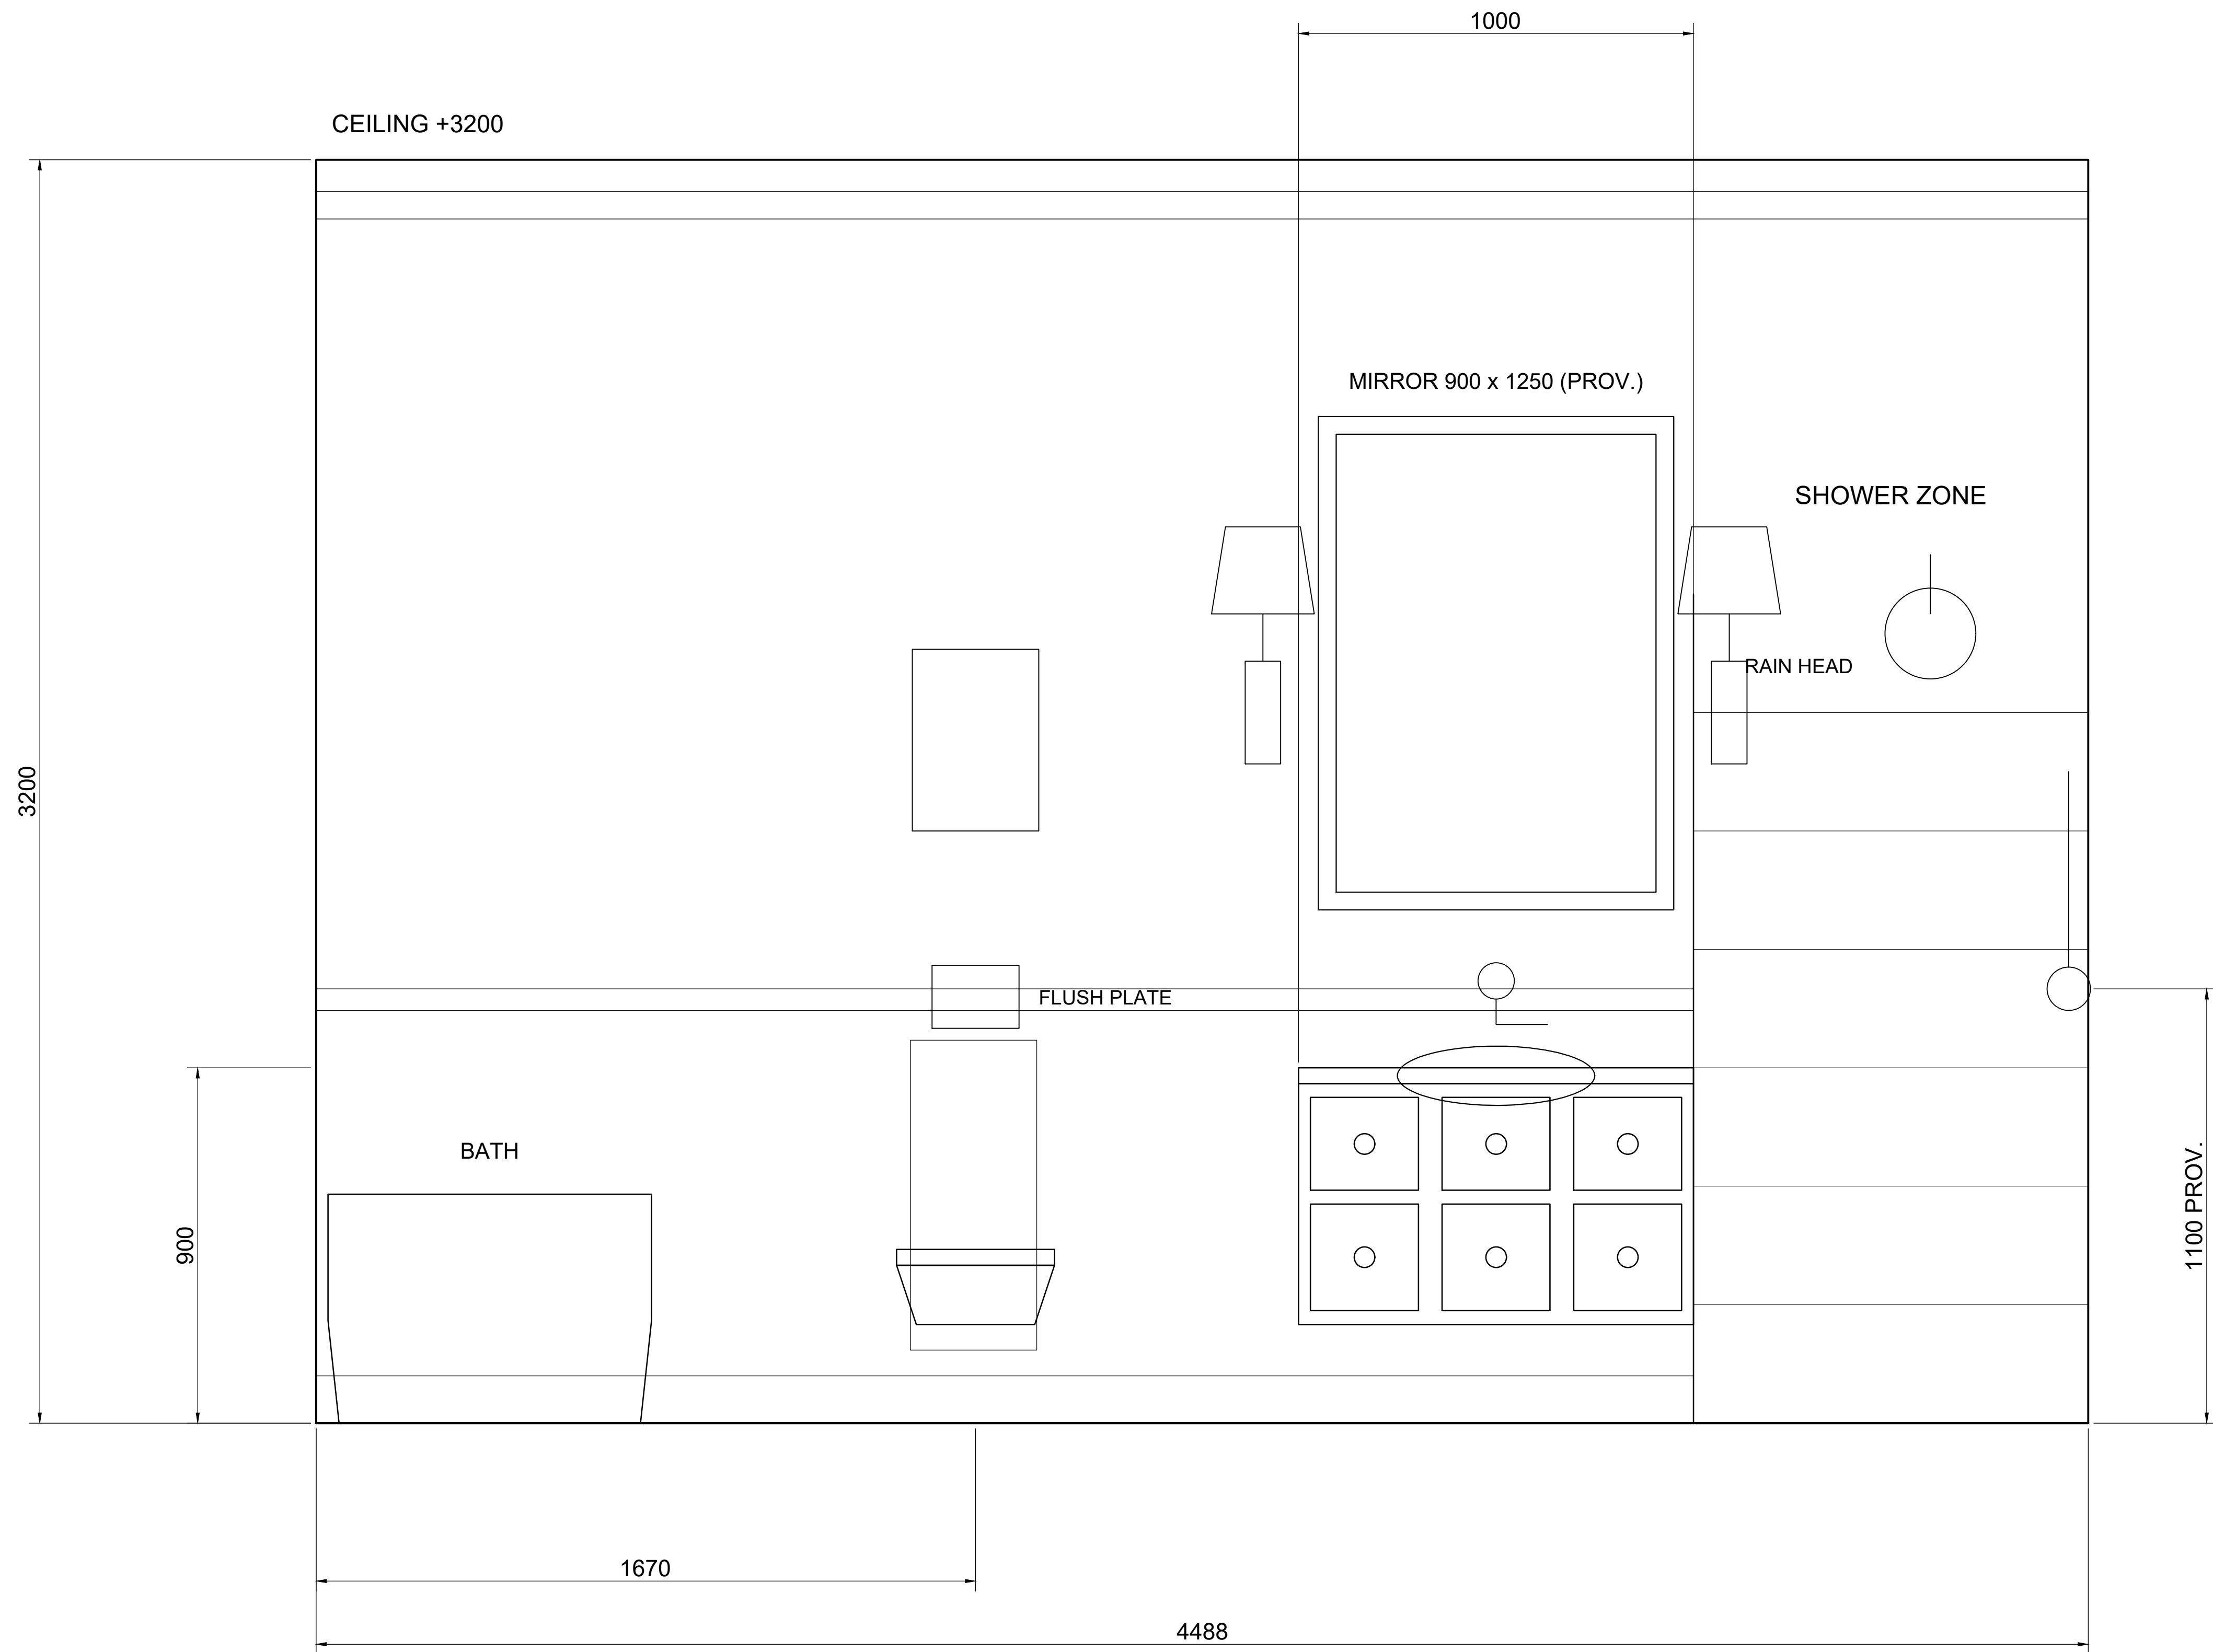

WALL 2 NOTES

- COUNTER TOP AT 900 AFF.
- VANITY 1381 LONG x 600 DEEP PER PLAN.
- MIRROR AND SCONCES CENTRED ON THE BASIN;
SCONCES SYMMETRICAL AT 590.5 EACH SIDE.
- WC CENTRELINE 1200 FROM THE SOUTH WALL.
- CONCEALED CISTERN WITH BRASS FLUSH PLATE.
- SHOWER FITTINGS SHOWN WITHIN SHOWER ZONE.
- MIRROR SIZE, DADO AND ART PROPORTIONED
FROM REFERENCE - CONFIRM IF REQUIRED.

KEY HEIGHTS (AFF)

FINISHED CEILING	3200
CORNICE SPRINGING	3050 PROV.
MIRROR TOP	2550 PROV.
SCONCE CENTRELINE	1800 PROV.
MIRROR BOTTOM	1300 PROV.
WALL TAP	1120 PROV.
DADO / PANEL RAIL	1100 PROV.
COUNTER TOP	900
TUB RIM	580 PROV.
WC SEAT	440 PROV.
SKIRTING	120 PROV.

WALL 2 - VANITY + WC

VIEW LOOKING WEST (left = SOUTH, right = NORTH)

RED CHANDELIER STUDIO

SHEET 03


WALL 2 VANITY + WC ELEVATION

SCALE 1:10 @ A1

UNITS mm REV V02
STATUS FOR CLIENT REVIEW

MASTER BATHROOM - INTERIOR CAD PACKAGE

SHEET 04 WALL 3 SHOWER ELEVATION

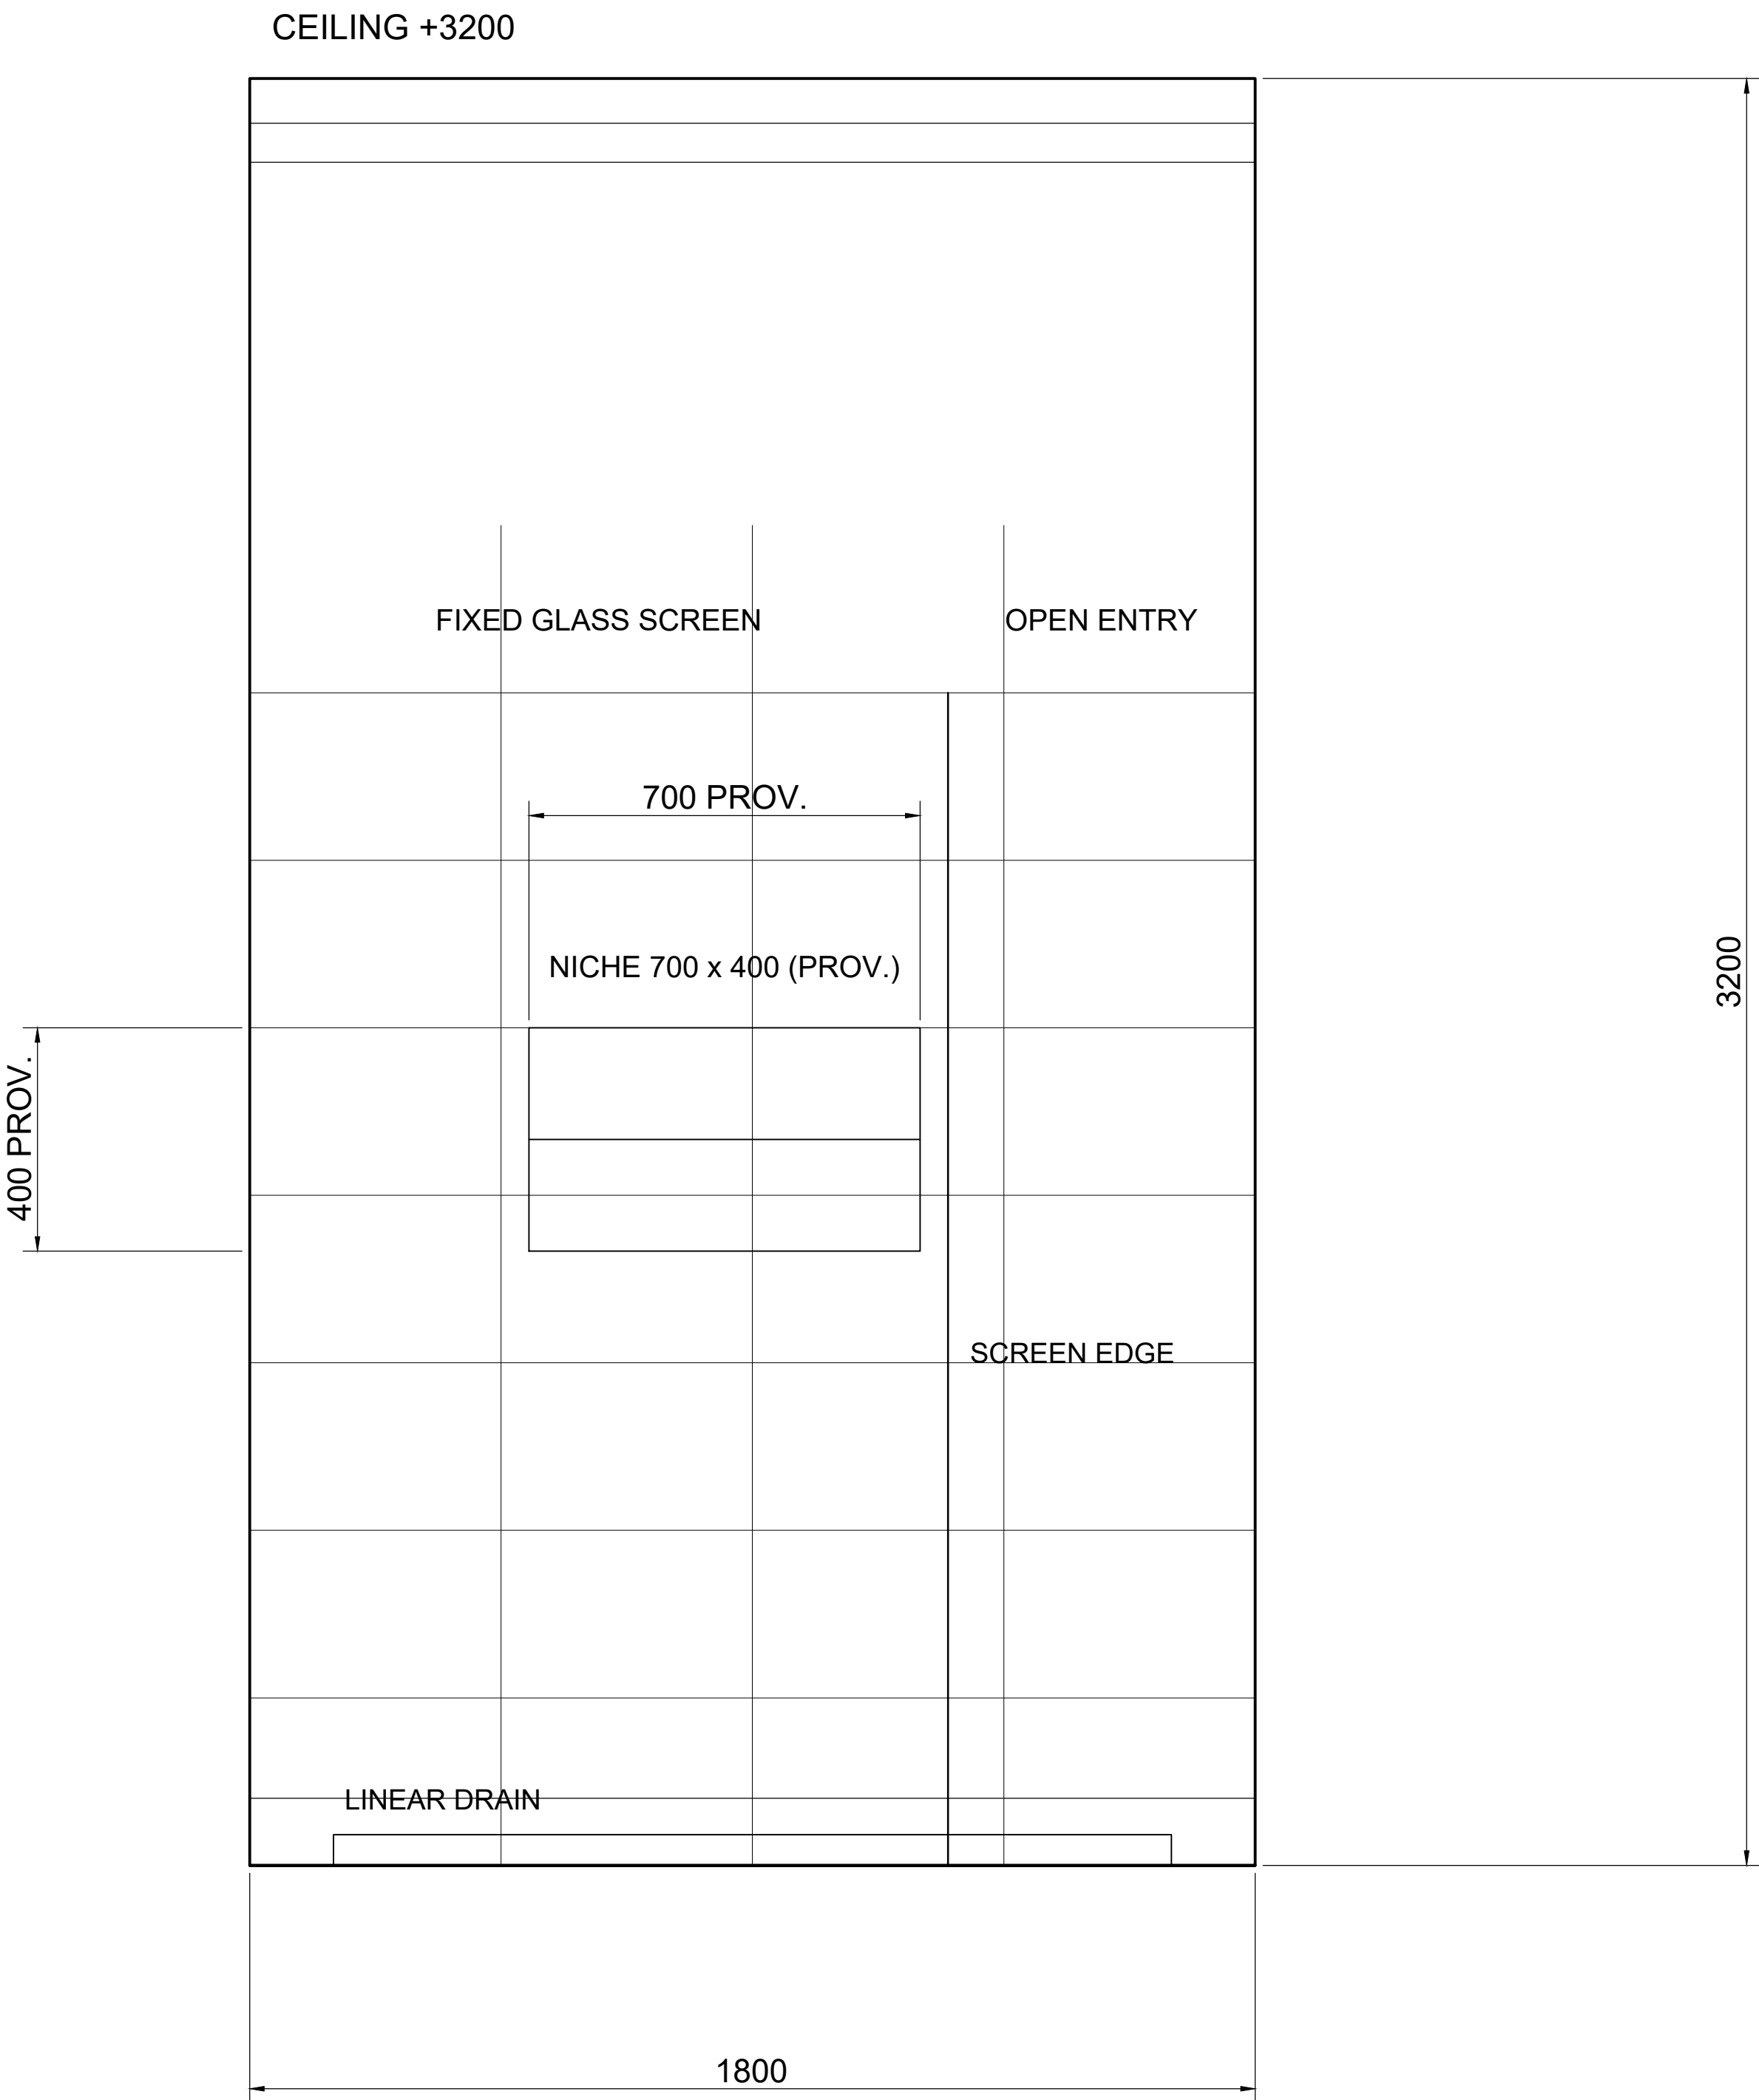

WALL 3 - SHOWER
VIEW LOOKING NORTH (left = WEST, right = EAST)

WALL 3 NOTES

- SHOWER 1800 WIDE x 1000 DEEP, TAKEN FROM THE SOURCE ENGINEERING CAD.
- FULL-WIDTH GLASS SCREEN ON THE SHOWER LINE WITH OPEN ENTRY TO THE EAST SIDE.
- FLOOR WASTE 288 FROM THE WEST WALL AGAINST THE NORTH WALL, PER SOURCE CAD.
- FULL-HEIGHT TILE CLADDING TO 2400 AFF.
- NICHE PROPORTIONED FROM REFERENCE.
- SHOWER FITTINGS ARE ON THE WEST WALL - SEE WALL 2 WITHIN THE SHOWER ZONE.

WET AREA NOTES

- FALLS TO THE LINEAR DRAIN TO BE SET OUT ON SITE BY THE INSTALLER.
- TANKING / WATERPROOFING IS NOT SHOWN - REFER TO THE SPECIALIST SPECIFICATION.
- NICHE AND FITTING POSITIONS TO BE COORDINATED WITH THE TILE SETTING OUT.
- GLASS TO BE CLEAR TOUGHENED SAFETY GLASS TO THE RELEVANT STANDARD.

SHOWER SETTING OUT

SHOWER WIDTH	1800	SOURCE CAD
SHOWER DEPTH	1000	SOURCE CAD
SCREEN LINE FROM SOUTH WALL	3488	SOURCE CAD
FLOOR WASTE FROM WEST WALL	288	SOURCE CAD
GLASS SCREEN LENGTH	1250	PROV.
OPEN ENTRY WIDTH	550	PROV.
TILE CLADDING HEIGHT	2400	PROV.
NICHE 700 x 400, SILL AFF	1100	PROV.
RAIN HEAD AFF	2000	PROV.

PROV. VALUES REQUIRE SITE CONFIRMATION.

RED CHANDELIER STUDIO

SHEET 04


WALL 3 SHOWER ELEVATION

SCALE 1:10 @ A1

UNITS mm REV V02
STATUS FOR CLIENT REVIEW

MASTER BATHROOM - INTERIOR CAD PACKAGE

SHEET 05 WALL 4 ENTRANCE / DOOR ELEVATION + SCHEDULES

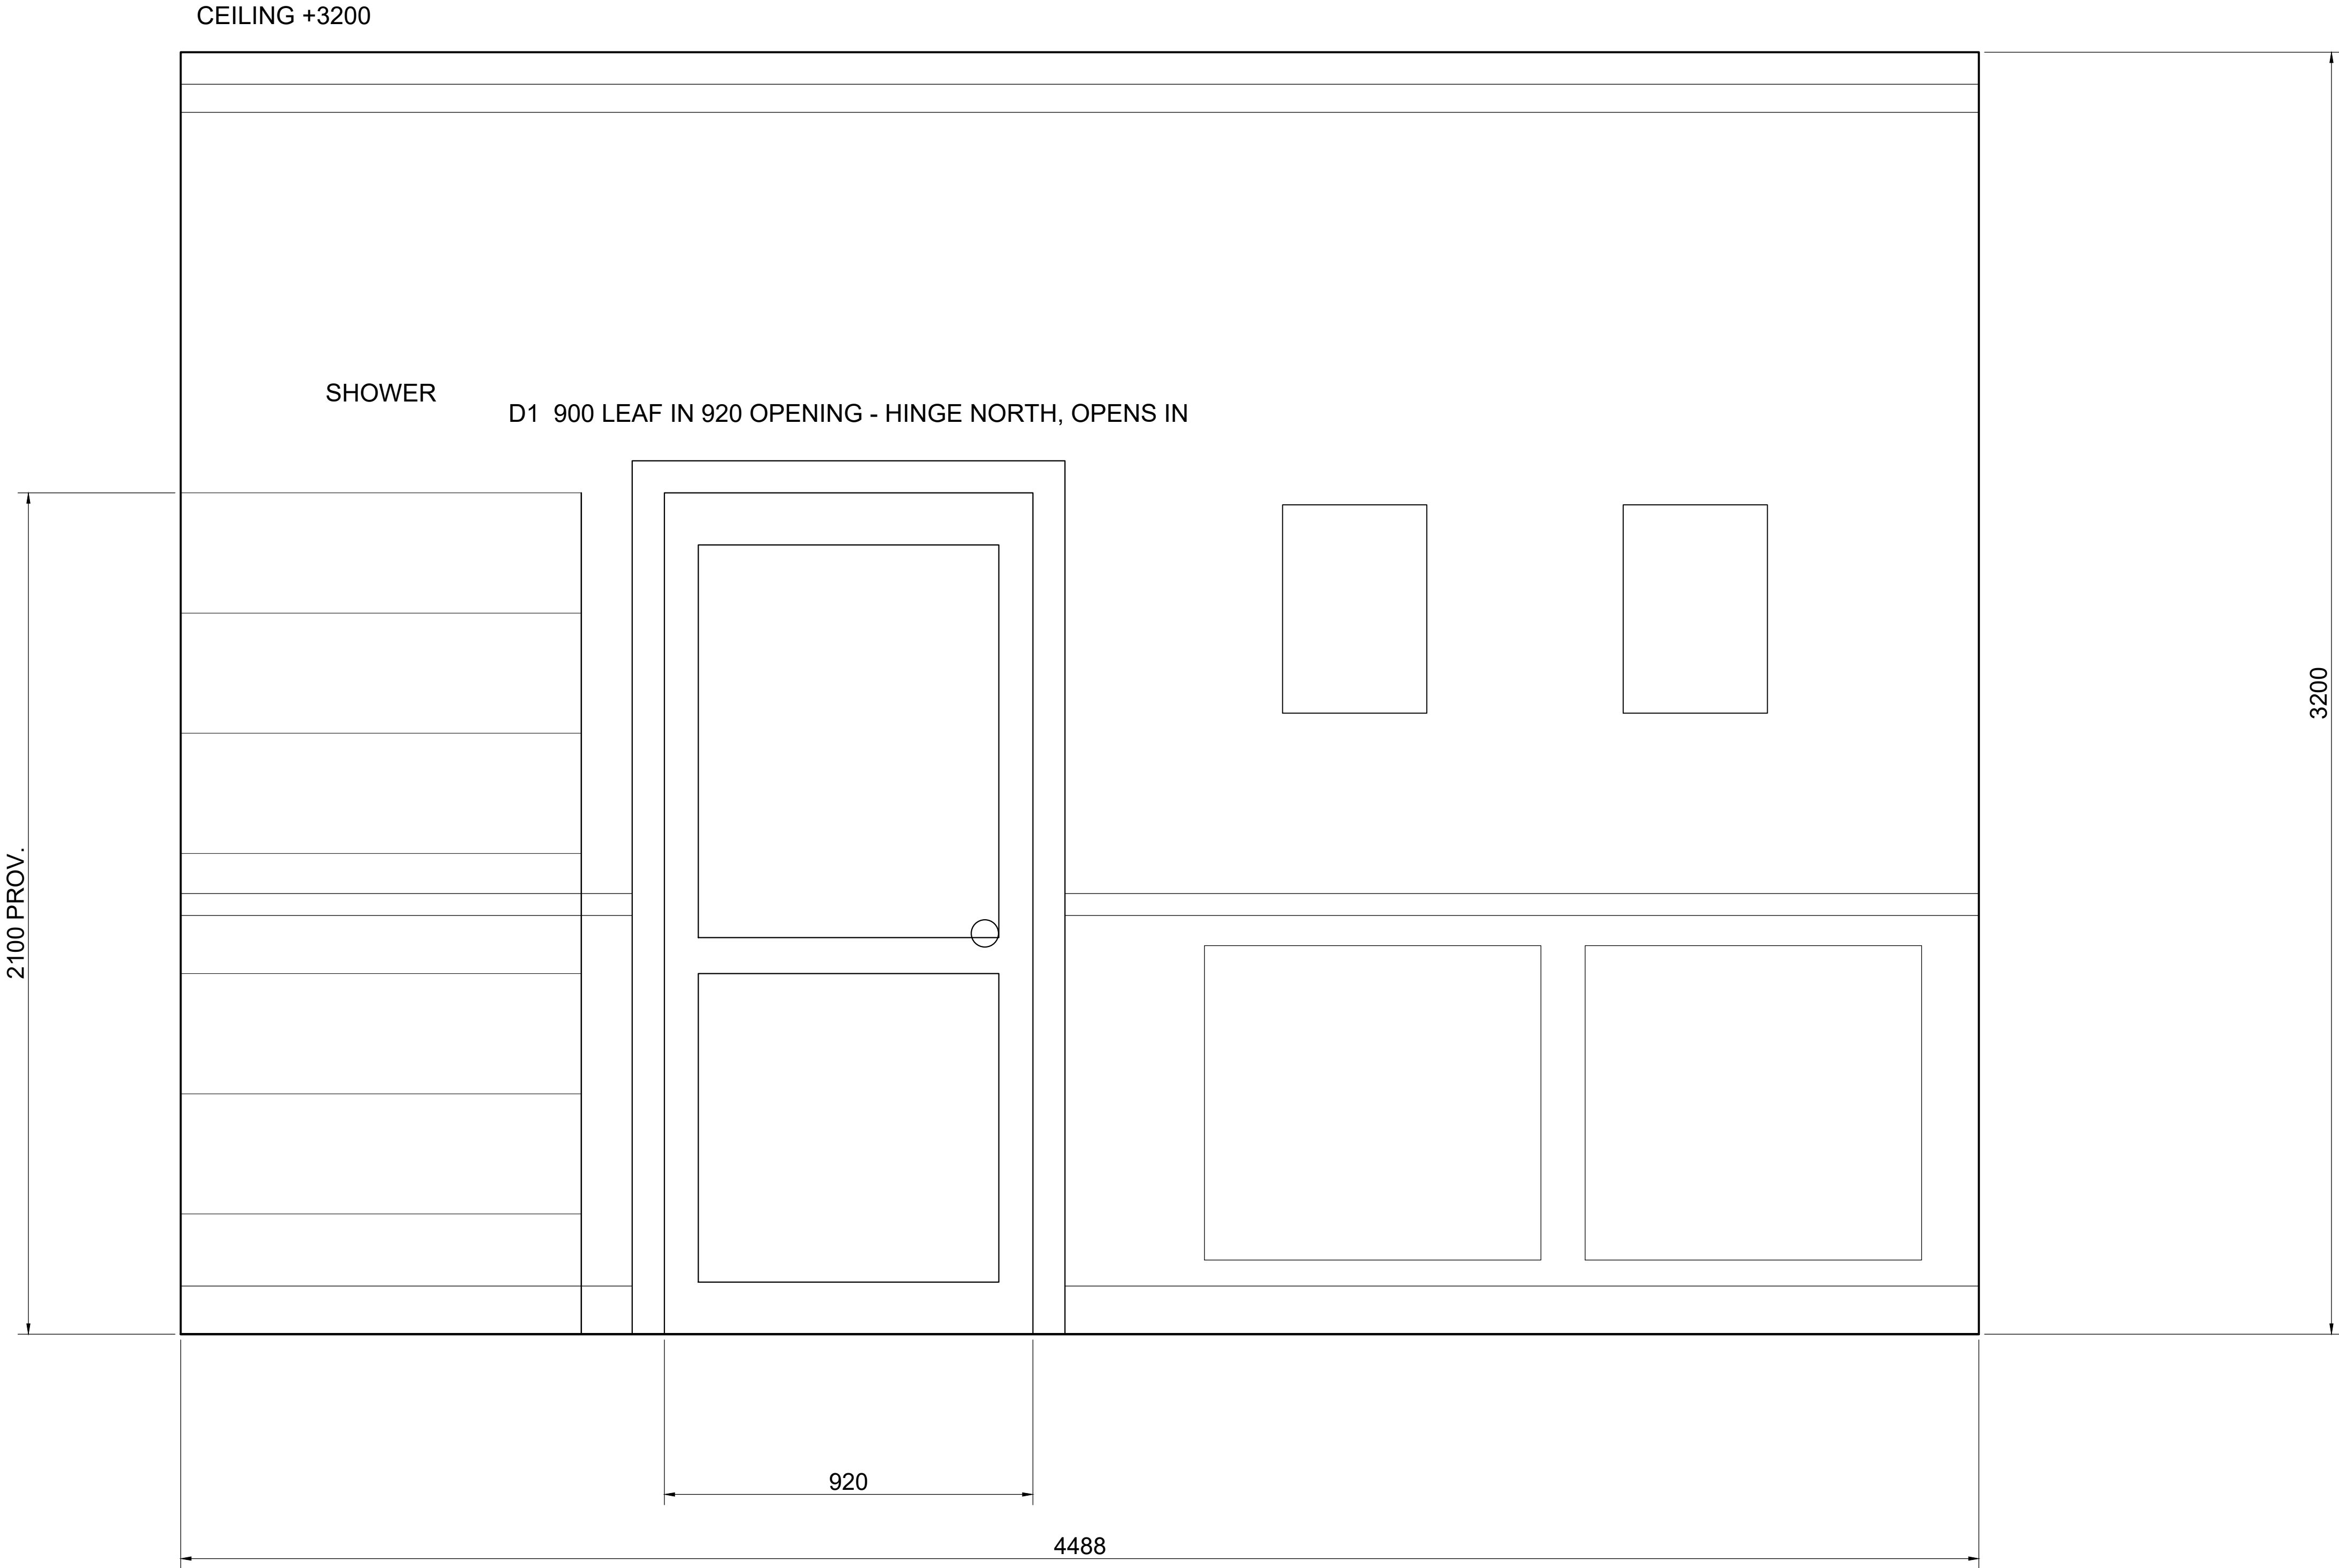

WALL 4 - ENTRANCE / DOOR

VIEW LOOKING EAST (left = NORTH, right = SOUTH)

MATERIAL LEGEND

ASSUMPTIONS / PROVISIONAL SCHEDULE

SOURCE CAD (NOT PROVISIONAL):

- ROOM 1800 x 4488 INTERNAL, WALLS 200 THICK.
- UNIFORM WIDTH - THERE IS NO STEPPED ZONE.
- BATH ELLIPSE 1803 x 844, WALL TO WALL.
- D1 900 LEAF IN 920 OPENING, HINGE NORTH.
- VANITY 1000 x 553. SHOWER 1800 x 1000.

PROVISIONAL - SITE VERIFY:

- P1 DADO 1100, SKIRTING 120, CORNICE 3050.
- P2 MIRROR 900 x 1250, SCONCE CL 1800 AFF.
- P3 NICHE 700 x 400. TUB RIM 580.
- P4 WC POSITION AND SIZE.
- P5 DOOR LEAF HEIGHT 2100.

- M1 MOSAIC FLOOR TILE, LIGHT BEIGE
- M2 VERTICAL WALL TILE / CLADDING
- M3 PAINTED PANELLED JOINERY
- M4 STONE VANITY TOP
- M5 BRUSHED BRASS SANITARYWARE
- M6 CLEAR TOUGHENED SHOWER GLASS

RED CHANDELIER STUDIO

SHEET 05


WALL 4 ENTRANCE / DOOR ELEVATION + SCHEDULES

SCALE 1:10 @ A1

UNITS mm REV V02
STATUS FOR CLIENT REVIEW

MASTER BATHROOM - INTERIOR CAD PACKAGE

SHEET 06 REFLECTED CEILING / LIGHTING PLAN

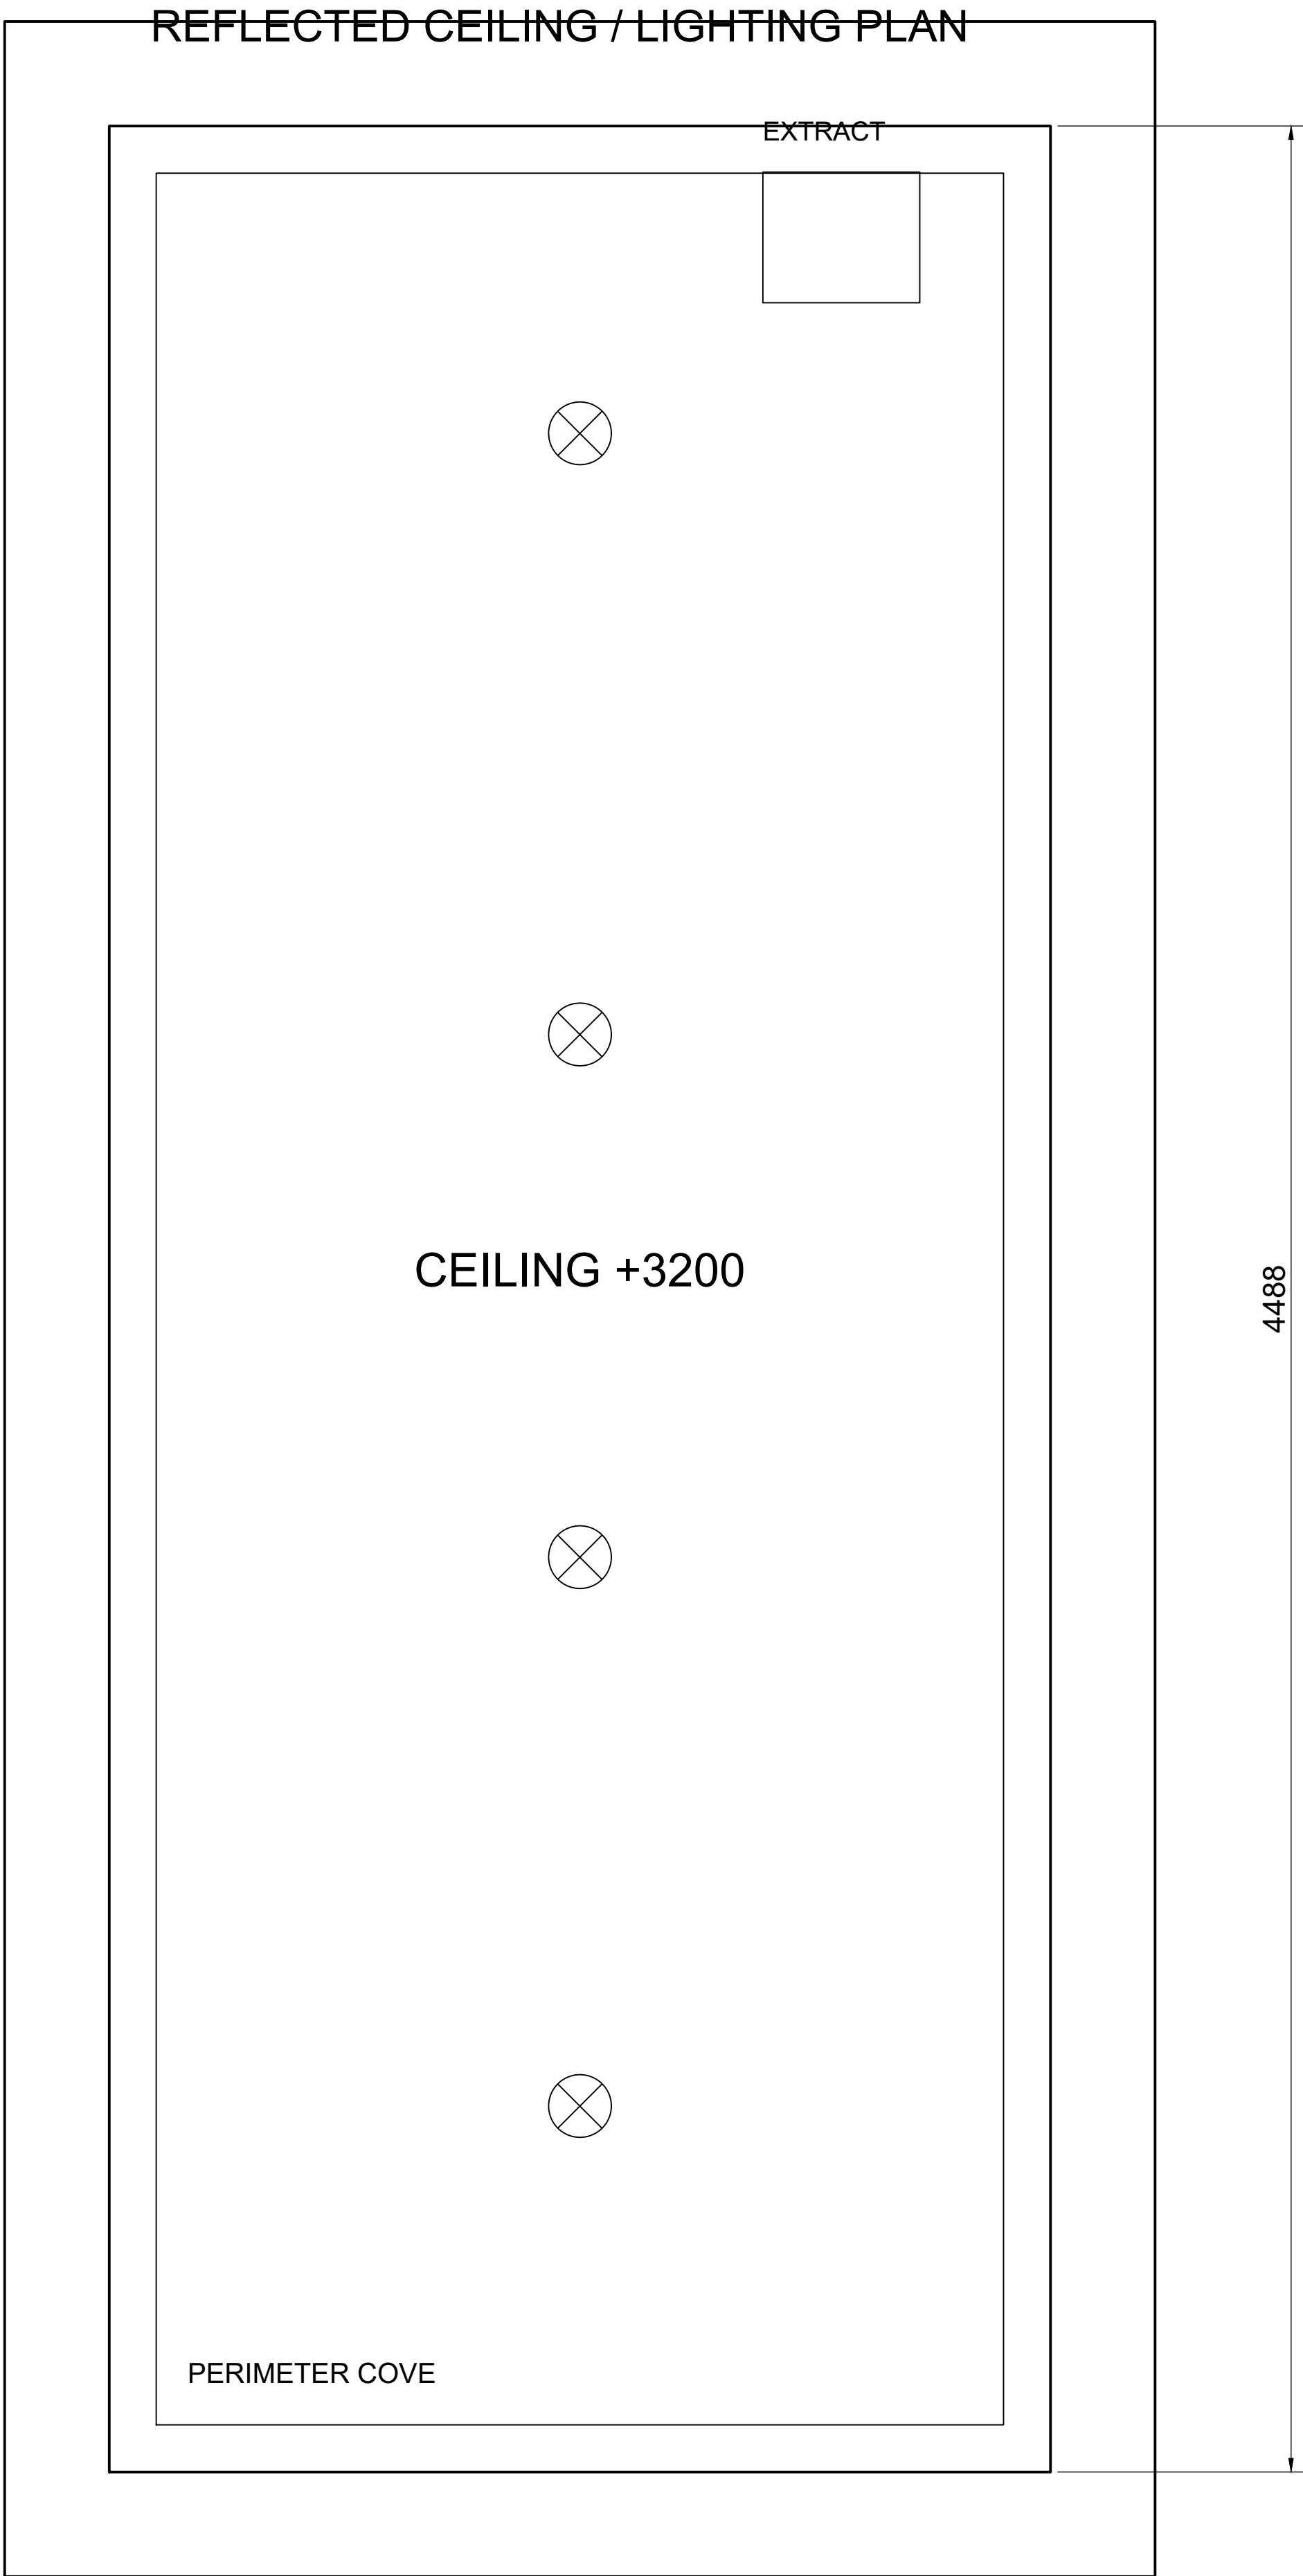

LIGHTING LEGEND

- O RECESSED DOWNLIGHT
- == PERIMETER COVE LIGHTING
- S WALL SCONCE (SEE WALL 2)
- ☐ EXTRACT / VENTILATION

CEILING NOTES

- FINISHED CEILING LEVEL +3200 THROUGHOUT.
- FOUR RECESSED DOWNLIGHTS ON THE ROOM CENTRELINE, ONE OVER EACH ZONE.
- PERIMETER COVE LIGHTING TO THE CEILING EDGE PER THE DESIGN REFERENCES.
- EXTRACT SHOWN INDICATIVELY OVER THE SHOWER ZONE.
- LIGHTING LAYOUT IS INDICATIVE ONLY AND SUBJECT TO SERVICES COORDINATION.
- SCONCES ARE WALL MOUNTED - SEE WALL 2.

CONFIRMED DIMENSIONS

CEILING HEIGHT	3200
ROOM INTERNAL WIDTH	1800
ROOM INTERNAL LENGTH	4488

DOWNLIGHT SETTING OUT

ALL DOWNLIGHTS ON THE ROOM CENTRELINE
AT X = 861.5 FROM THE WEST WALL.

- DL1 700 FROM SOUTH WALL (OVER BATH)
- DL2 1750 FROM SOUTH WALL
- DL3 2750 FROM SOUTH WALL (OVER VANITY)
- DL4 3900 FROM SOUTH WALL (OVER SHOWER)

SETTING OUT IS INDICATIVE - CONFIRM WITH
THE SERVICES DRAWINGS BEFORE INSTALLATION.

SHEET INDEX

- 01 GENERAL ARRANGEMENT PLAN
- 02 WALL 1 BATHTUB + WINDOW
- 03 WALL 2 VANITY + WC
- 04 WALL 3 SHOWER
- 05 WALL 4 ENTRANCE / DOOR
- 06 REFLECTED CEILING / LIGHTING

RED CHANDELIER STUDIO

SHEET 06

REFLECTED CEILING / LIGHTING PLAN

SCALE 1:10 @ A1

UNITS mm REV V02
STATUS FOR CLIENT REVIEW